
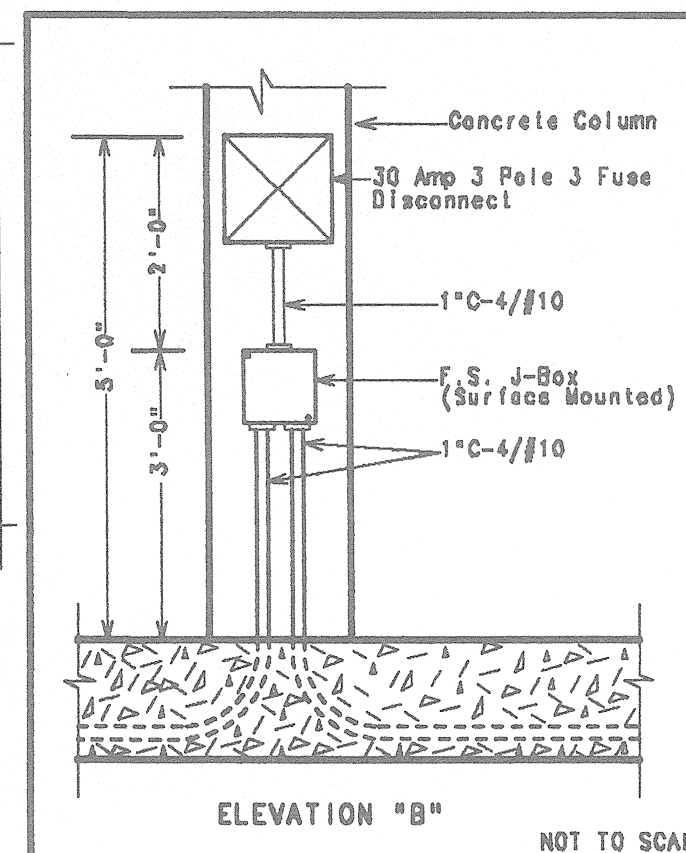
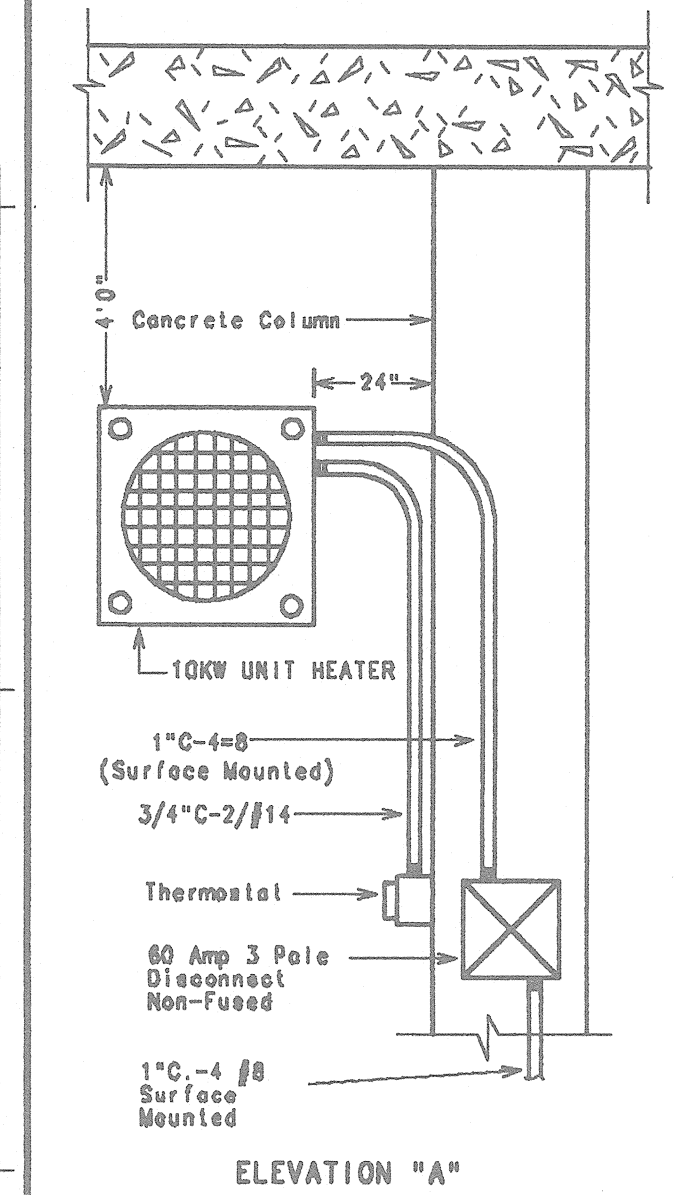


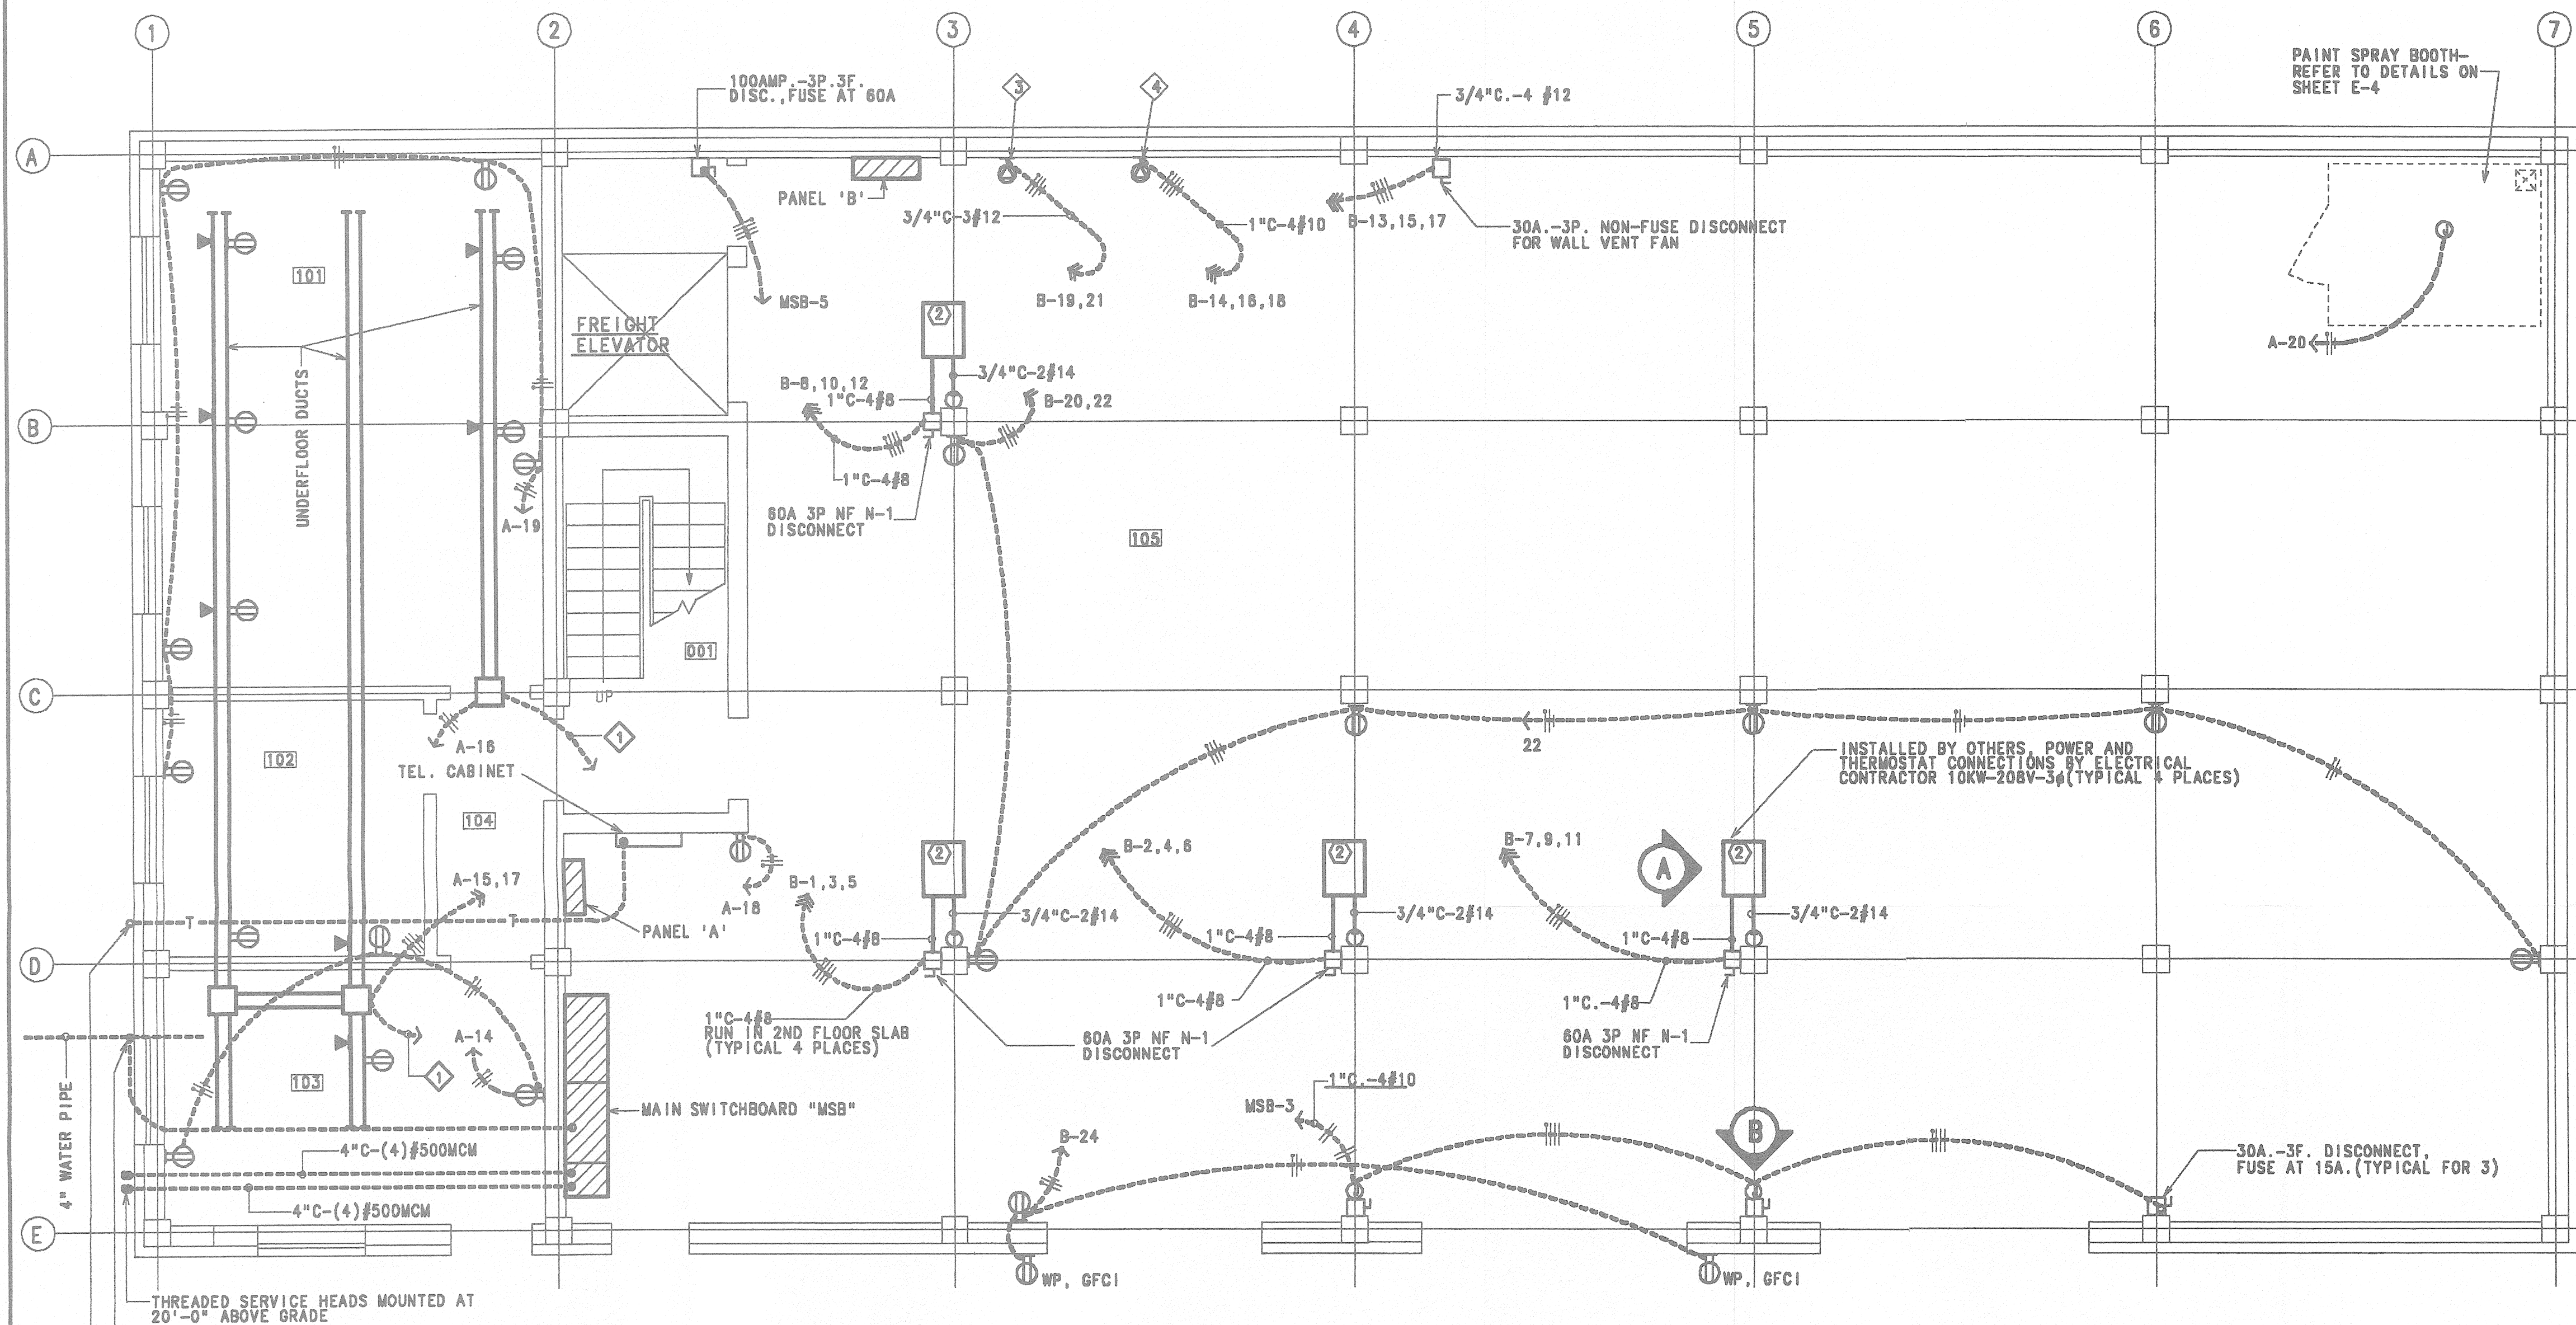

ROOM SCHEDULE

- 101 Business Office
- 102 Manager's Office
- 103 Sales Office
- 104 Corridor
- 105 Warehouse Area — 1st Floor
- 001 Stairs

ELECTRICAL SHEET NOTES:

- 1 1 1/4" conduit to telephone cabinet for future telephone cables.
- 2 All circuits to receptacles shall be run in the first floor slab, in the masonry walls, or in concrete columns unless noted otherwise.
- 3 Special receptacle, 20A, 125/250V, NEMA 14-20R, Hubbell #8410.
- 4 Special receptacle, 30A, 125/250V, NEMA 14-30R, Hubbell #9430A.

FIRST FLOOR PLAN — POWER

OFFICE AND WAREHOUSE FOR ATLANTIC FOOD COMPANY

REVISIONS		JOB. NO.	DATE	DRAWING NO.
DATE				
		DRAWN BY	SCALE	E-2
			1/4"=1'-0"	